
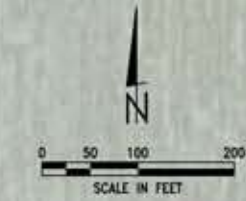


MAY 24, 2011 • 14:28:11 Location: C:\Projects\127-G1-108\Complete\18 Subd.dwg

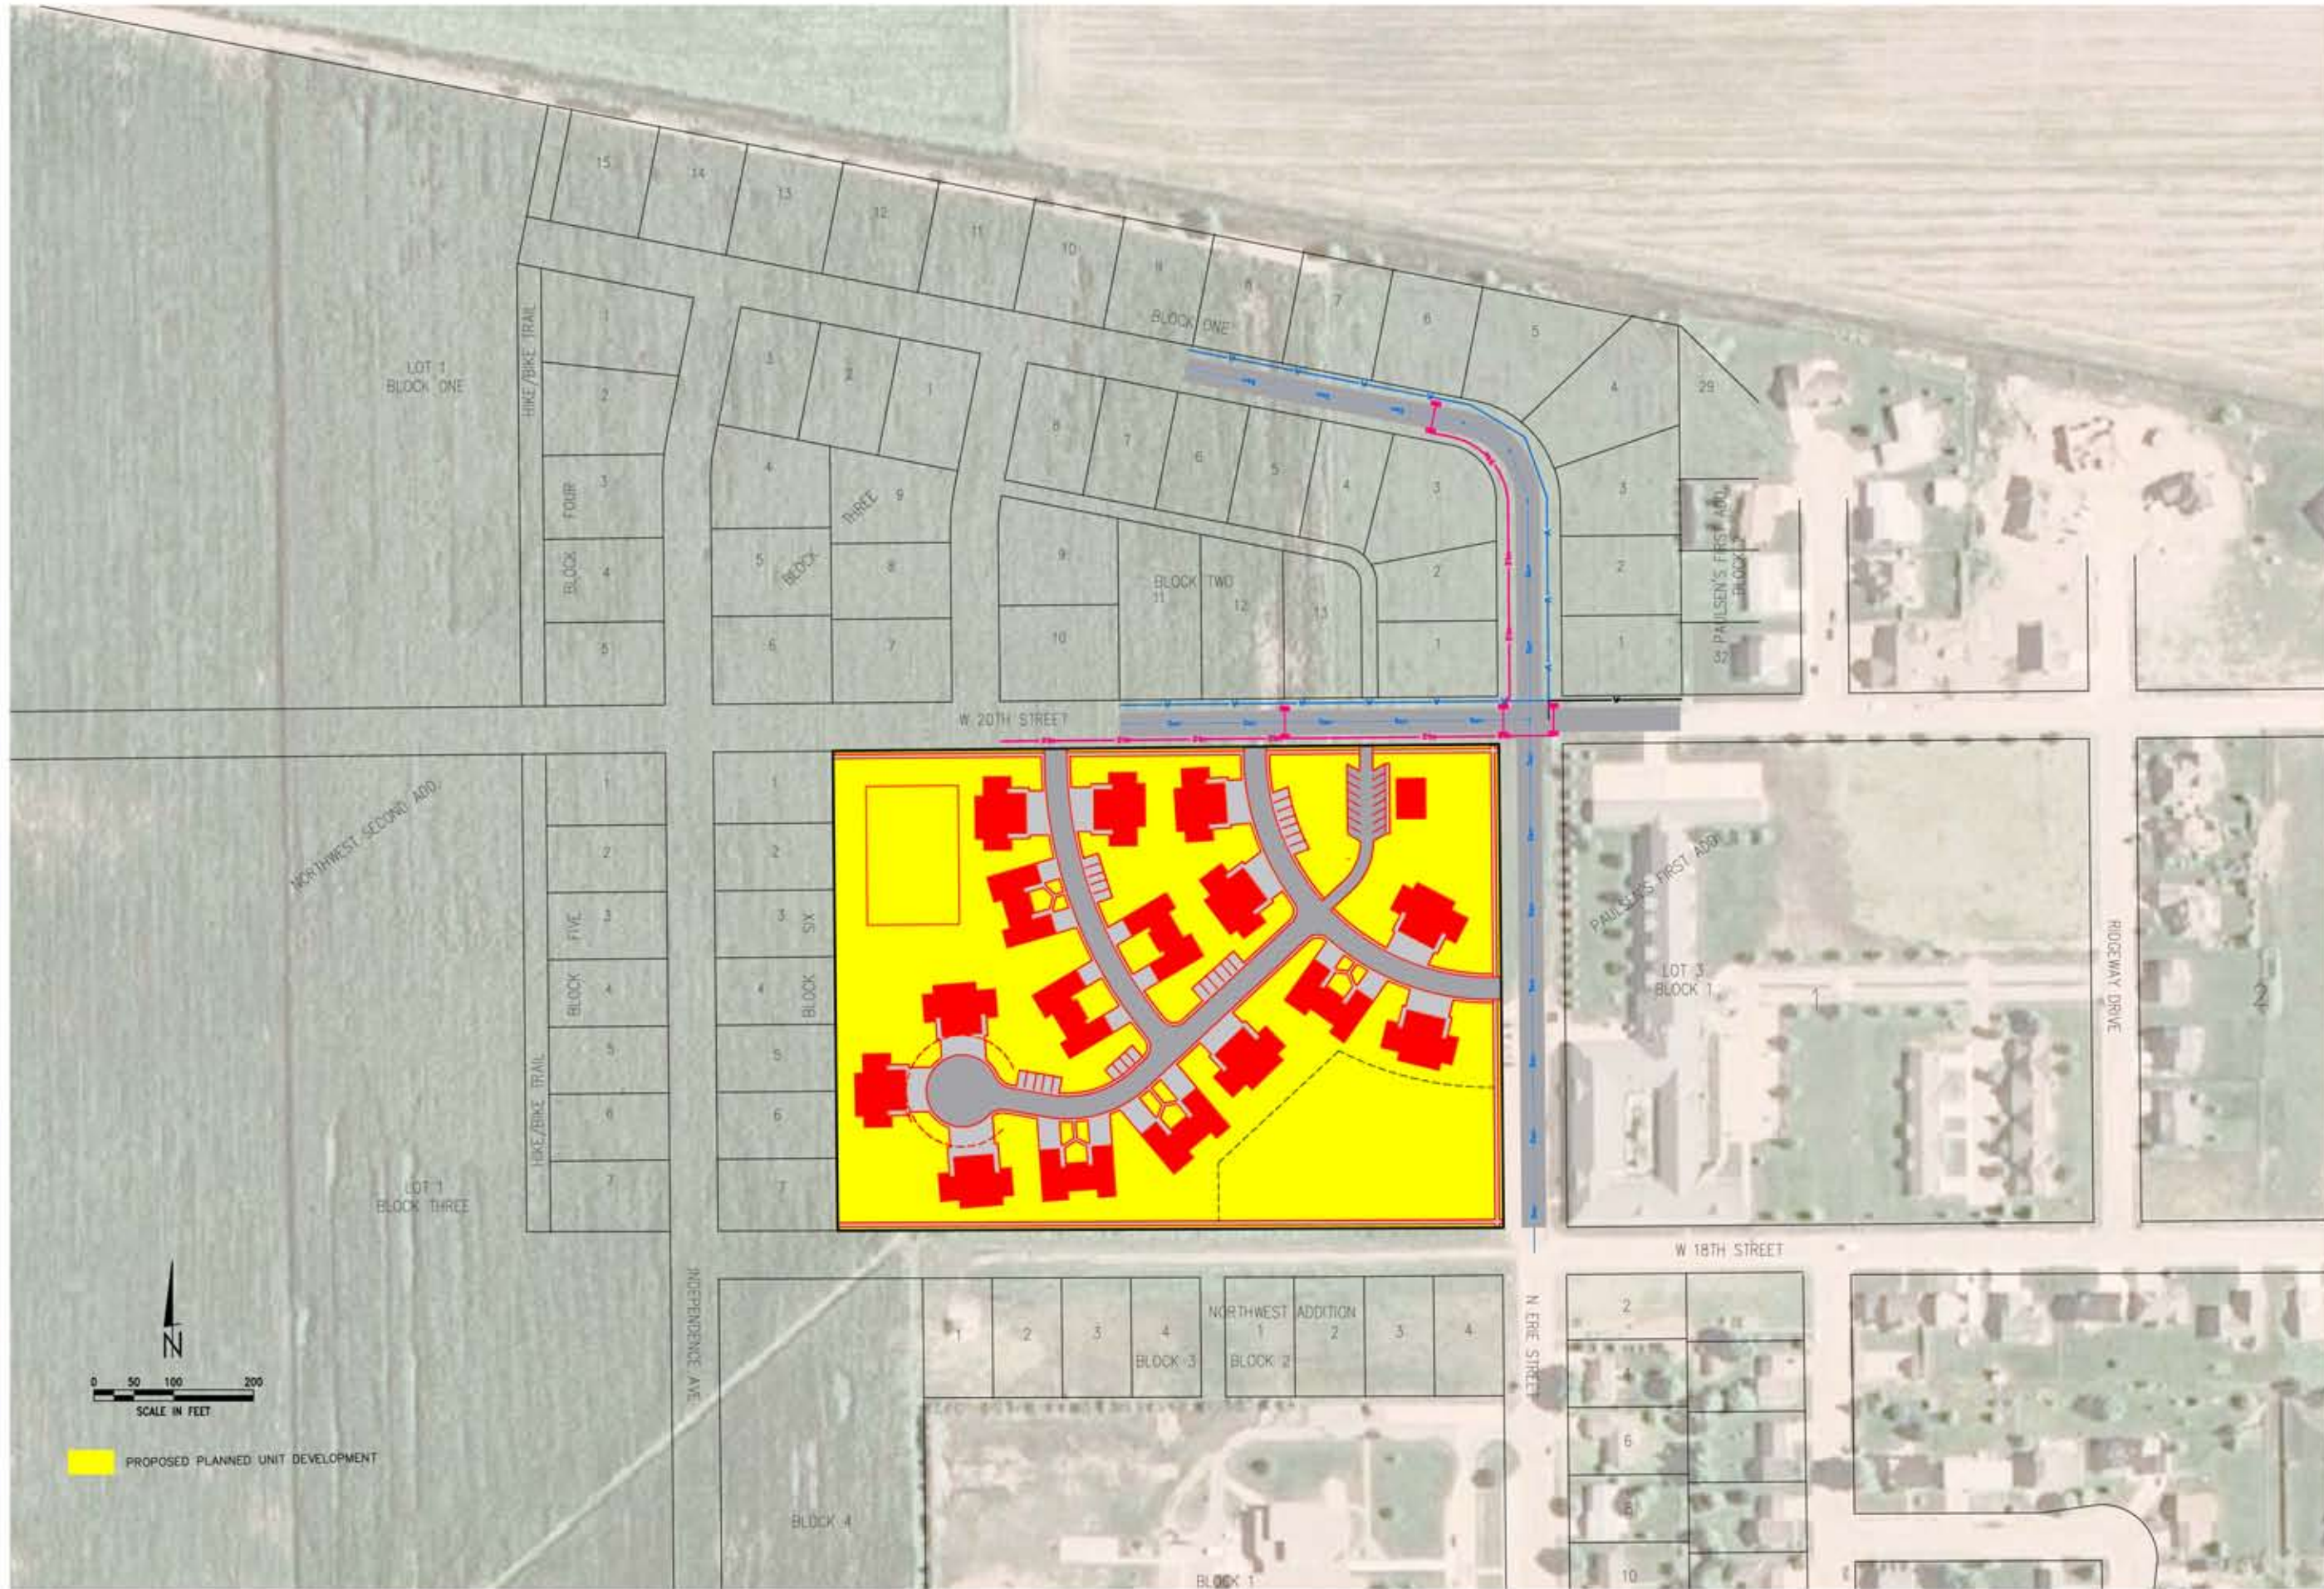

PROPOSED PLANNED UNIT DEVELOPMENT


REVISIONS	BY

M&A
 Miller & Associates
 Consulting Engineers, P.C.
 Kearney, NE (308) 234-8456
 McCook, NE (308) 345-3710

NORTHWEST SUBDIVISION
PROPOSED PLANNED UNIT DEVELOPMENT
 LEXINGTON, NEBRASKA 2011

VERIFY SCALES	
BAR IS ONE INCH ON ORIGINAL DRAWING	
0" = 1"	
IF NOT ONE INCH ON THIS SHEET, ADJUST SCALES ACCORDINGLY.	
SCALE:	AS SHOWN
PROJECT NO.	127-G1-108
DATE:	MAY, 2011
FIELD BOOK	M&A DWG NO.
DRAWN BY:	APRVD BY:
ACD	
SHEET	

This document, and the ideas and design incorporated herein, as an instrument of professional service, is the property of Miller & Associates and is not to be used in whole or in part, for any other project without the written authorization of Miller & Associates.

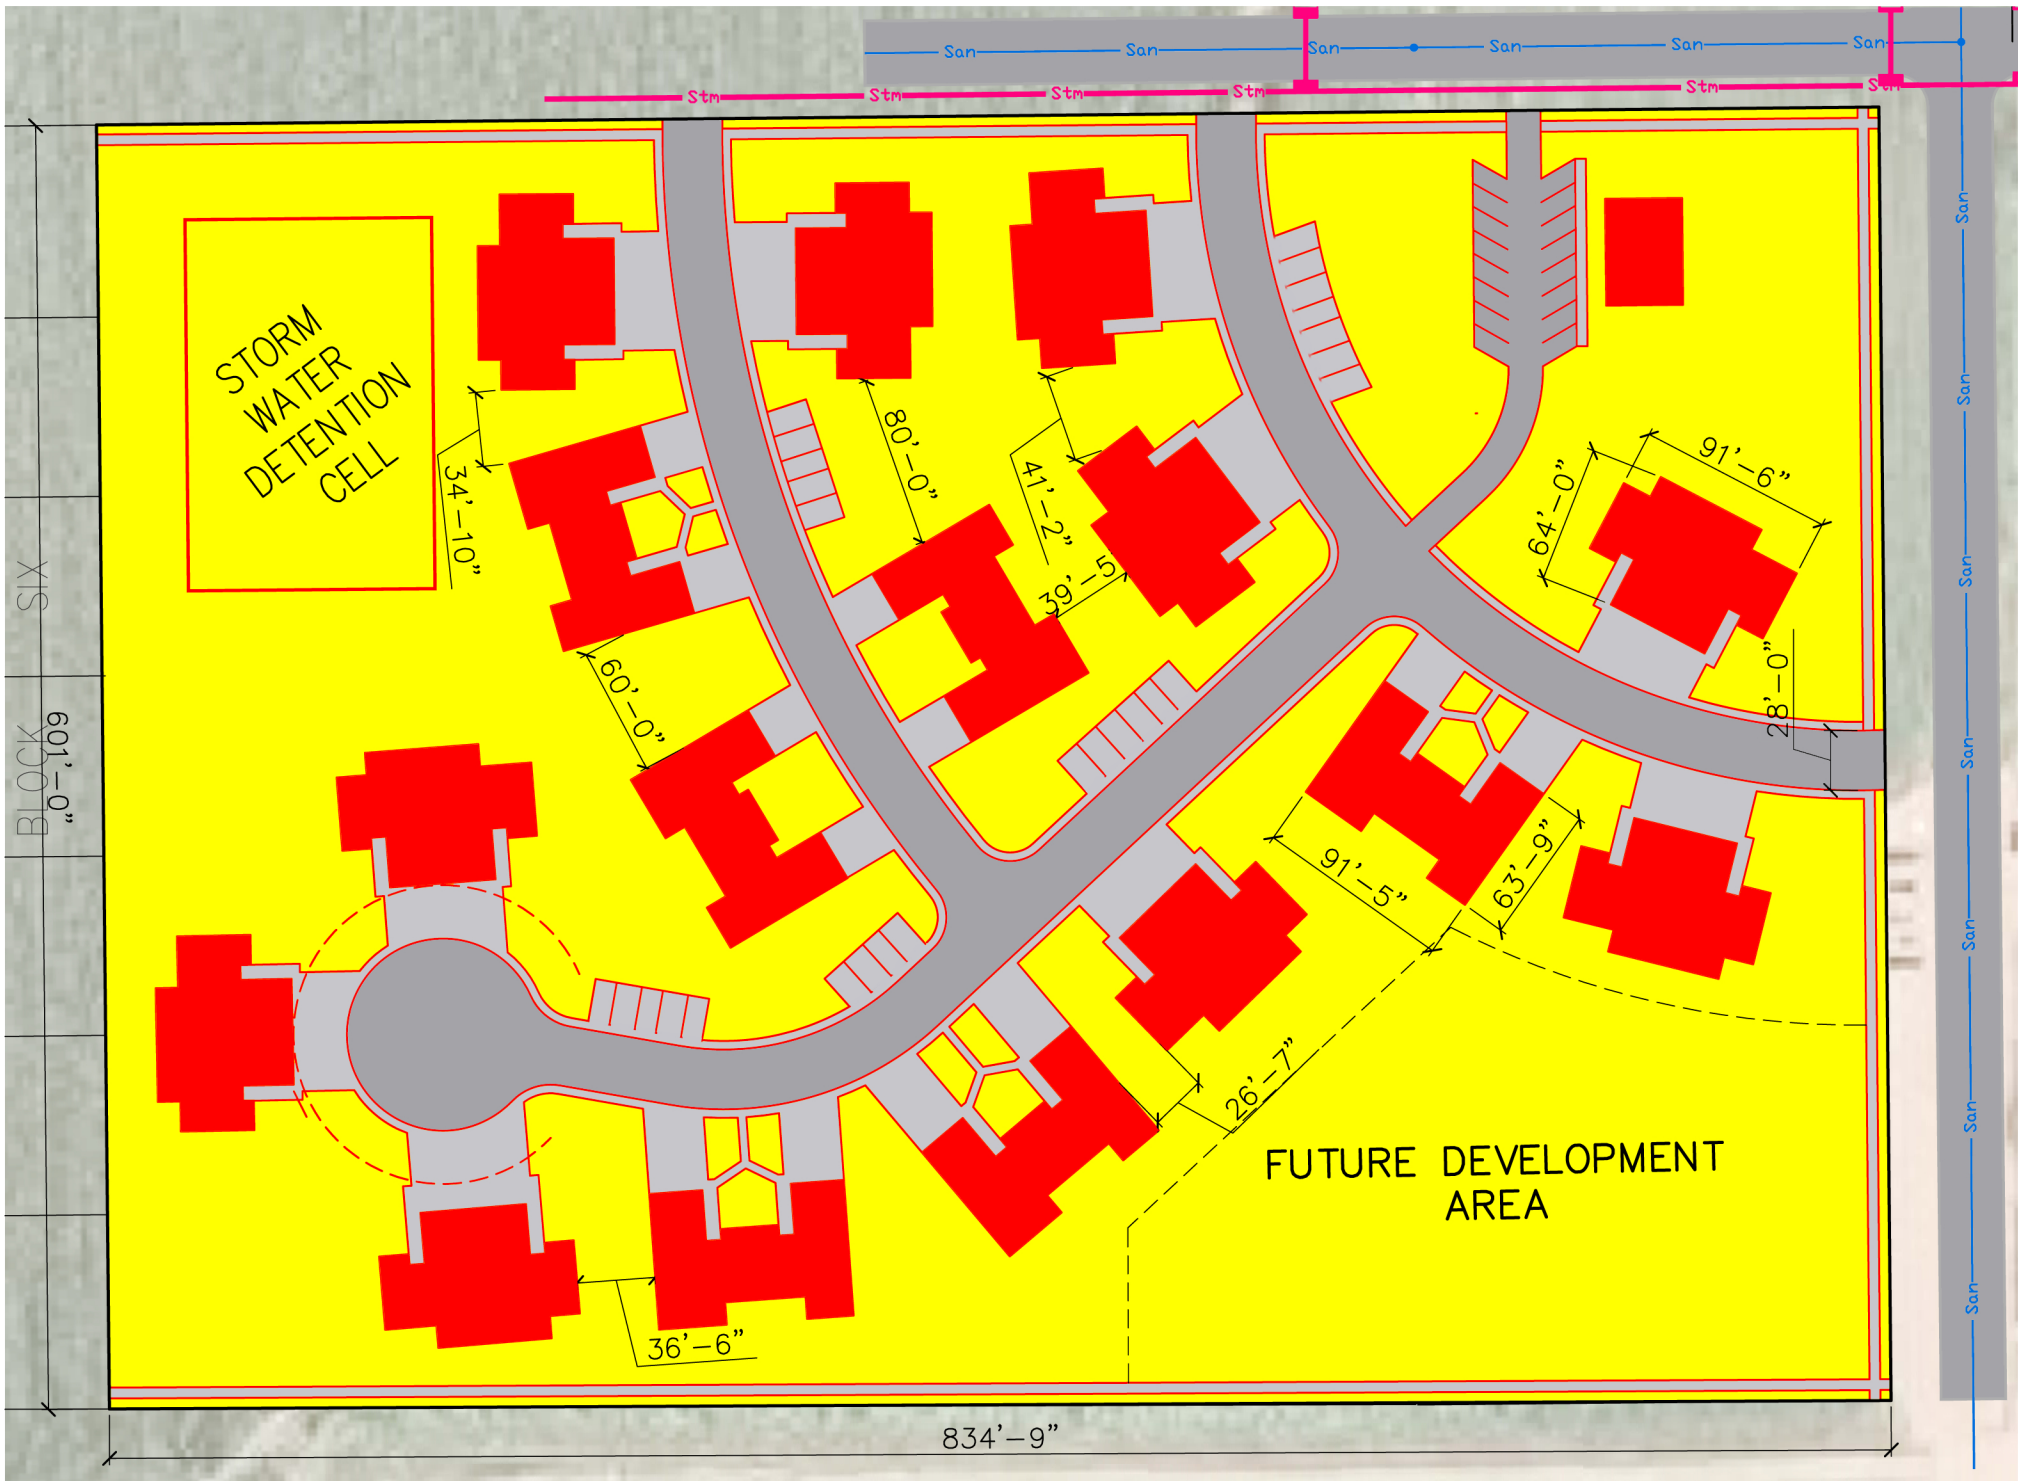

ENLARGED SITE PLAN
NO SCALE